


① (N)2ND FLOOR PLAN @ HOUSE
 1/4" = 1'-0" UPPER FLOOR @ 1,170 S.F. NORTH

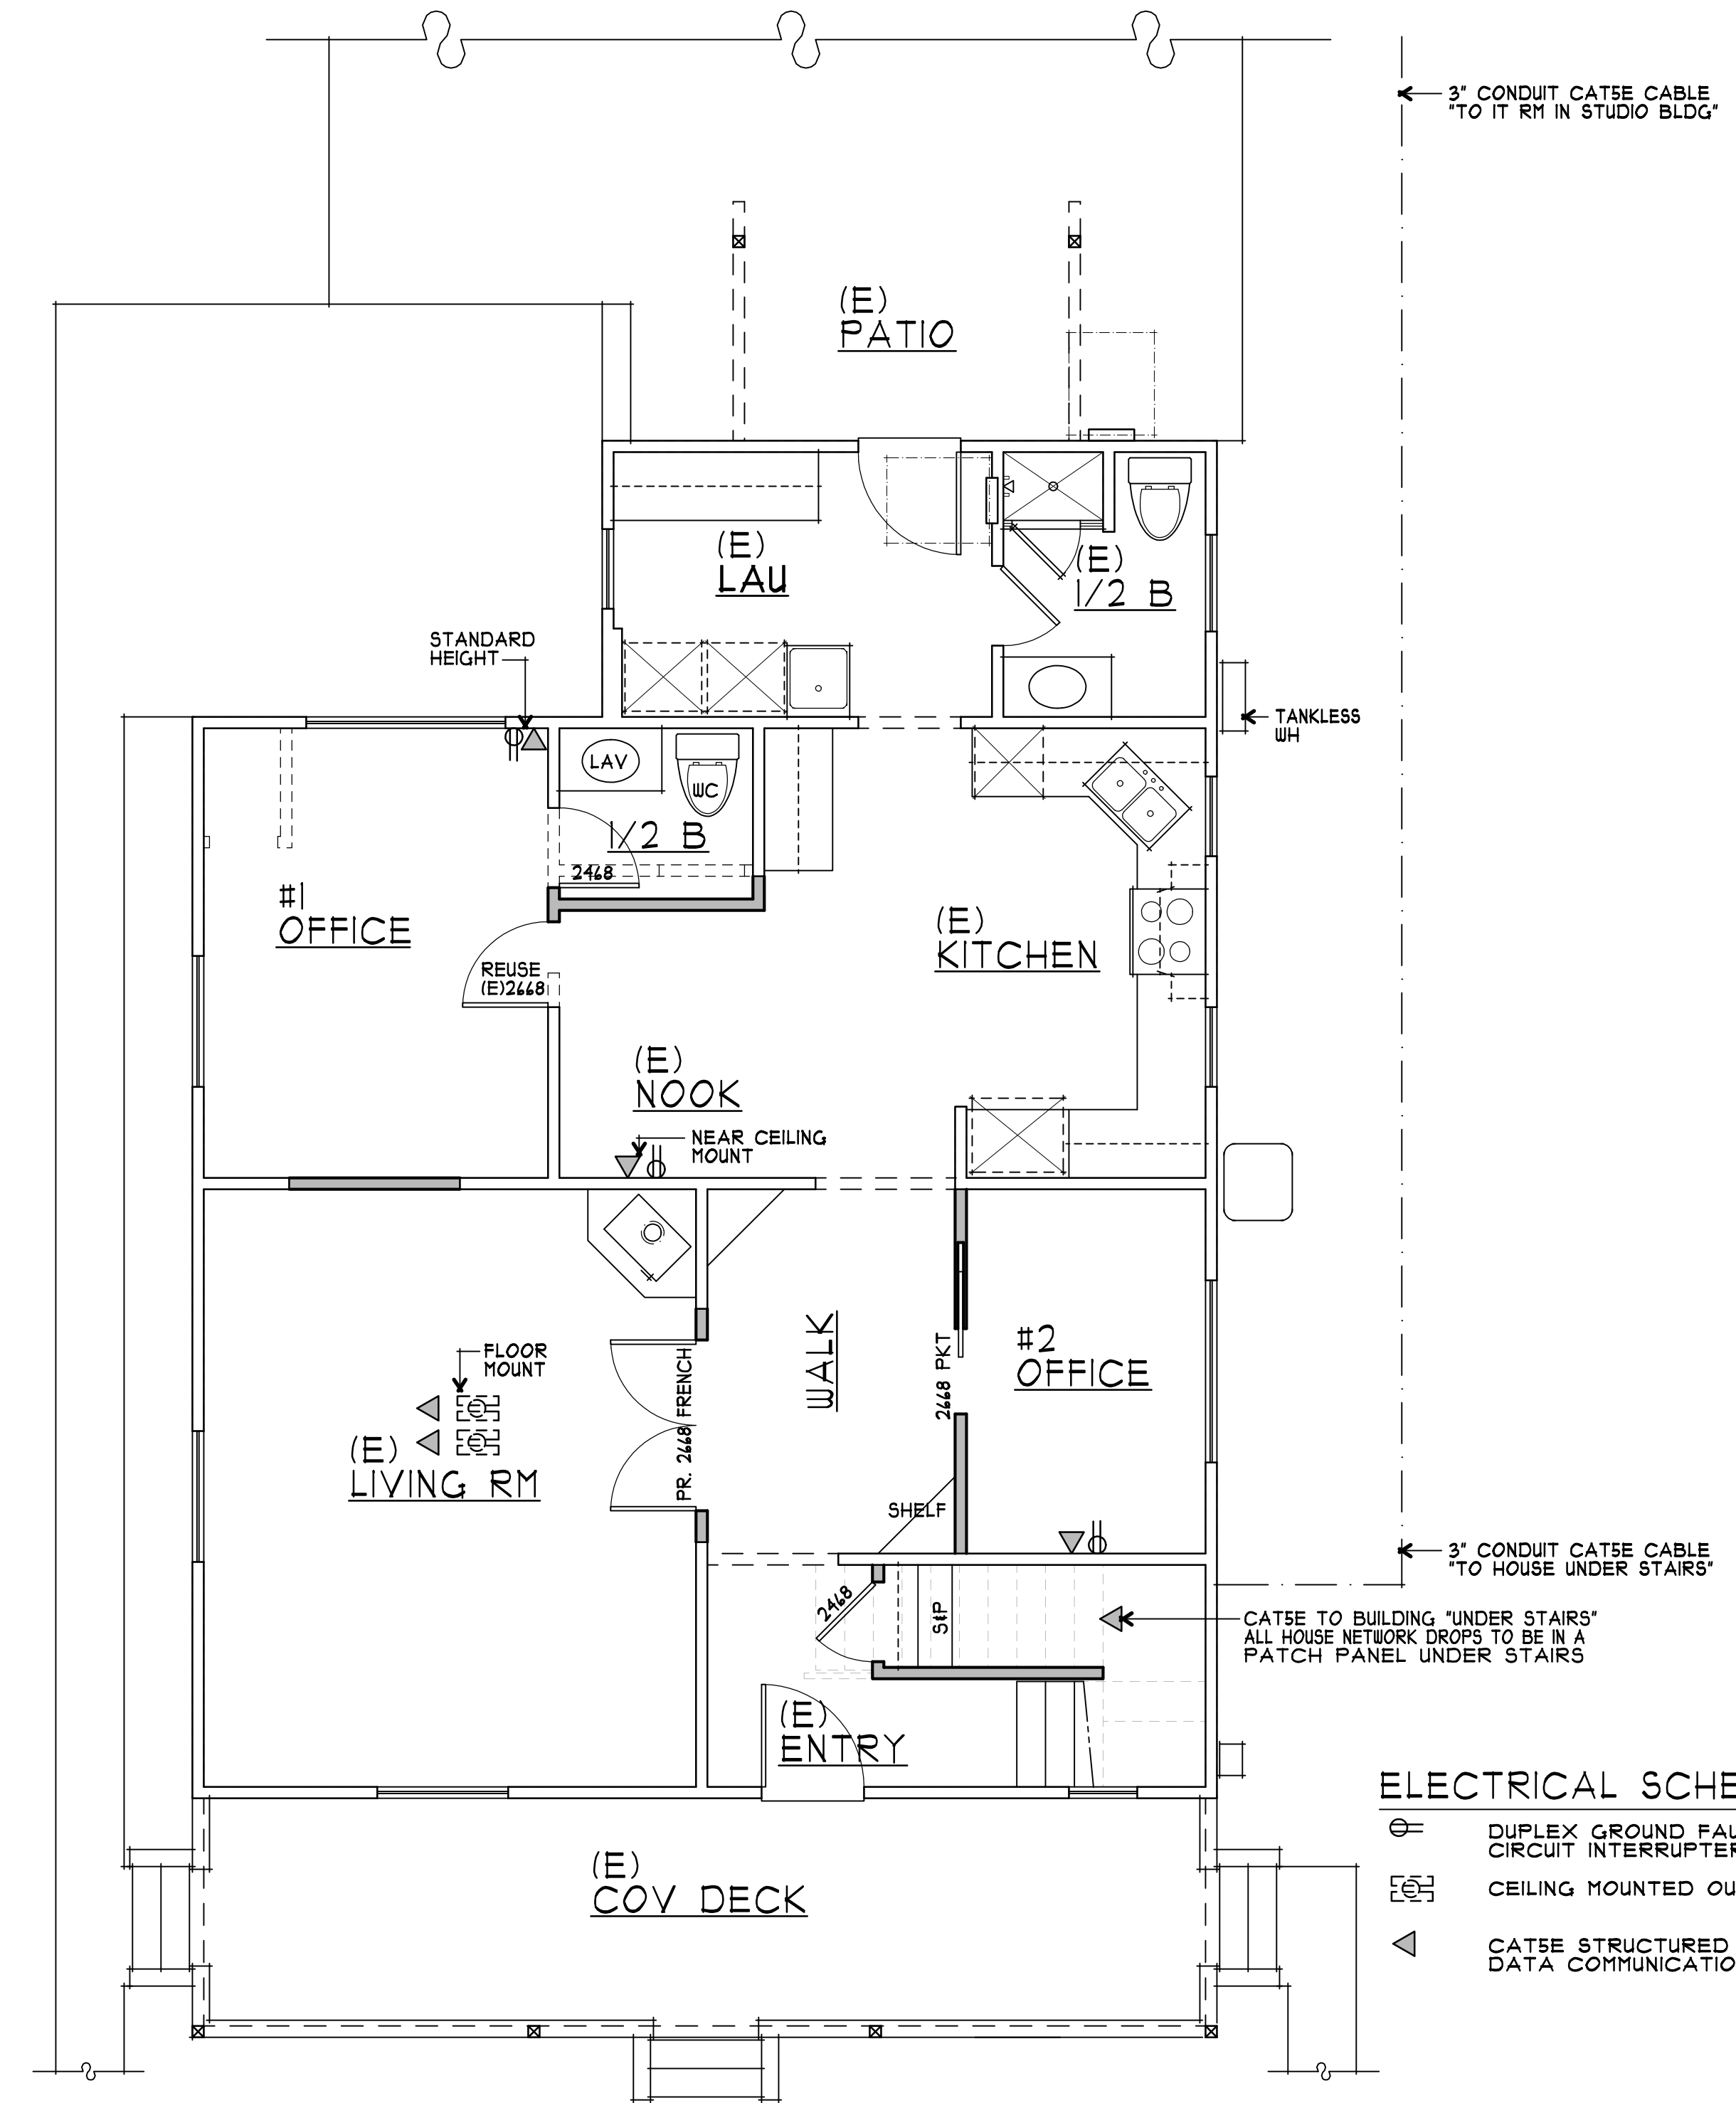

② (N)1ST FLOOR PLAN @ HOUSE
 1/4" = 1'-0" MAIN FLOOR @ 1,100 S.F. NORTH

- ELECTRICAL SCHEDULE**
- ⊕ DUPLEX GROUND FAULT CIRCUIT INTERRUPTER
 - ⊕ CEILING MOUNTED OUTLET
 - ▲ CATSE STRUCTURED WIRE-TV, PHONE, DATA COMMUNICATIONS, & FIBER

- WALL SCHEDULE**
- EXISTING WALL
 - NEW WALL
 - - - EXISTING WALL (TO BE REMOVED)

CHRIS VINCENT
 CONSTRUCTION
 (541) 973-7293

A PROPOSED INTERIOR ROOM REMODEL FOR:
PTW AMERICAN INC
 111 CEDAR DRIVE, ROGUE RIVER, OREGON

drawings
 (N)1ST & 2ND
 FLR PLN @ HOUSE

project number
 1144-2

date
 JULY 2024

sheet number

5

of 6 sheets